




SIGHT DISTANCE PROFILE - Scale: H: 1"=10', V: 2.00:1

TOWN APPROVAL

 6/21/23
 TOWN PLANNER DATE
 6/24/23
 TOWN ENGINEER DATE

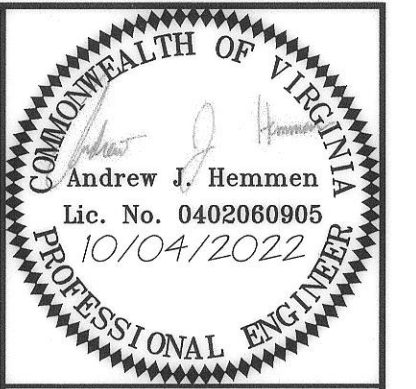

Draper Aden Associates
 Engineering • Surveying • Environmental Services
 1030 Wilmer Avenue, Suite 100
 Richmond, VA 23227
 804-264-2228 Fax: 804-264-8773
 www.daa.com



- Raleigh, NC
- Blacksburg, VA
- Fayetteville, NC
- Charlottesville, VA
- Northern Virginia
- Hampton Roads, VA
- Virginia Beach, VA

SITE DIMENSIONAL PLAN
PATRICK HENRY DRIVE BUS STOP
 PRICES FORK MAG. DISTRICT, BLACKSBURG, MONTGOMERY COUNTY, VIRGINIA


REVISIONS

NO.	DESCRIPTION


DESIGNED BY:	AJH
DRAWN BY:	MJR
CHECKED BY:	JEH
SCALE:	1" = 10'
DATE:	10/04/2022
PROJECT NUMBER:	2102060

C301

L-2042

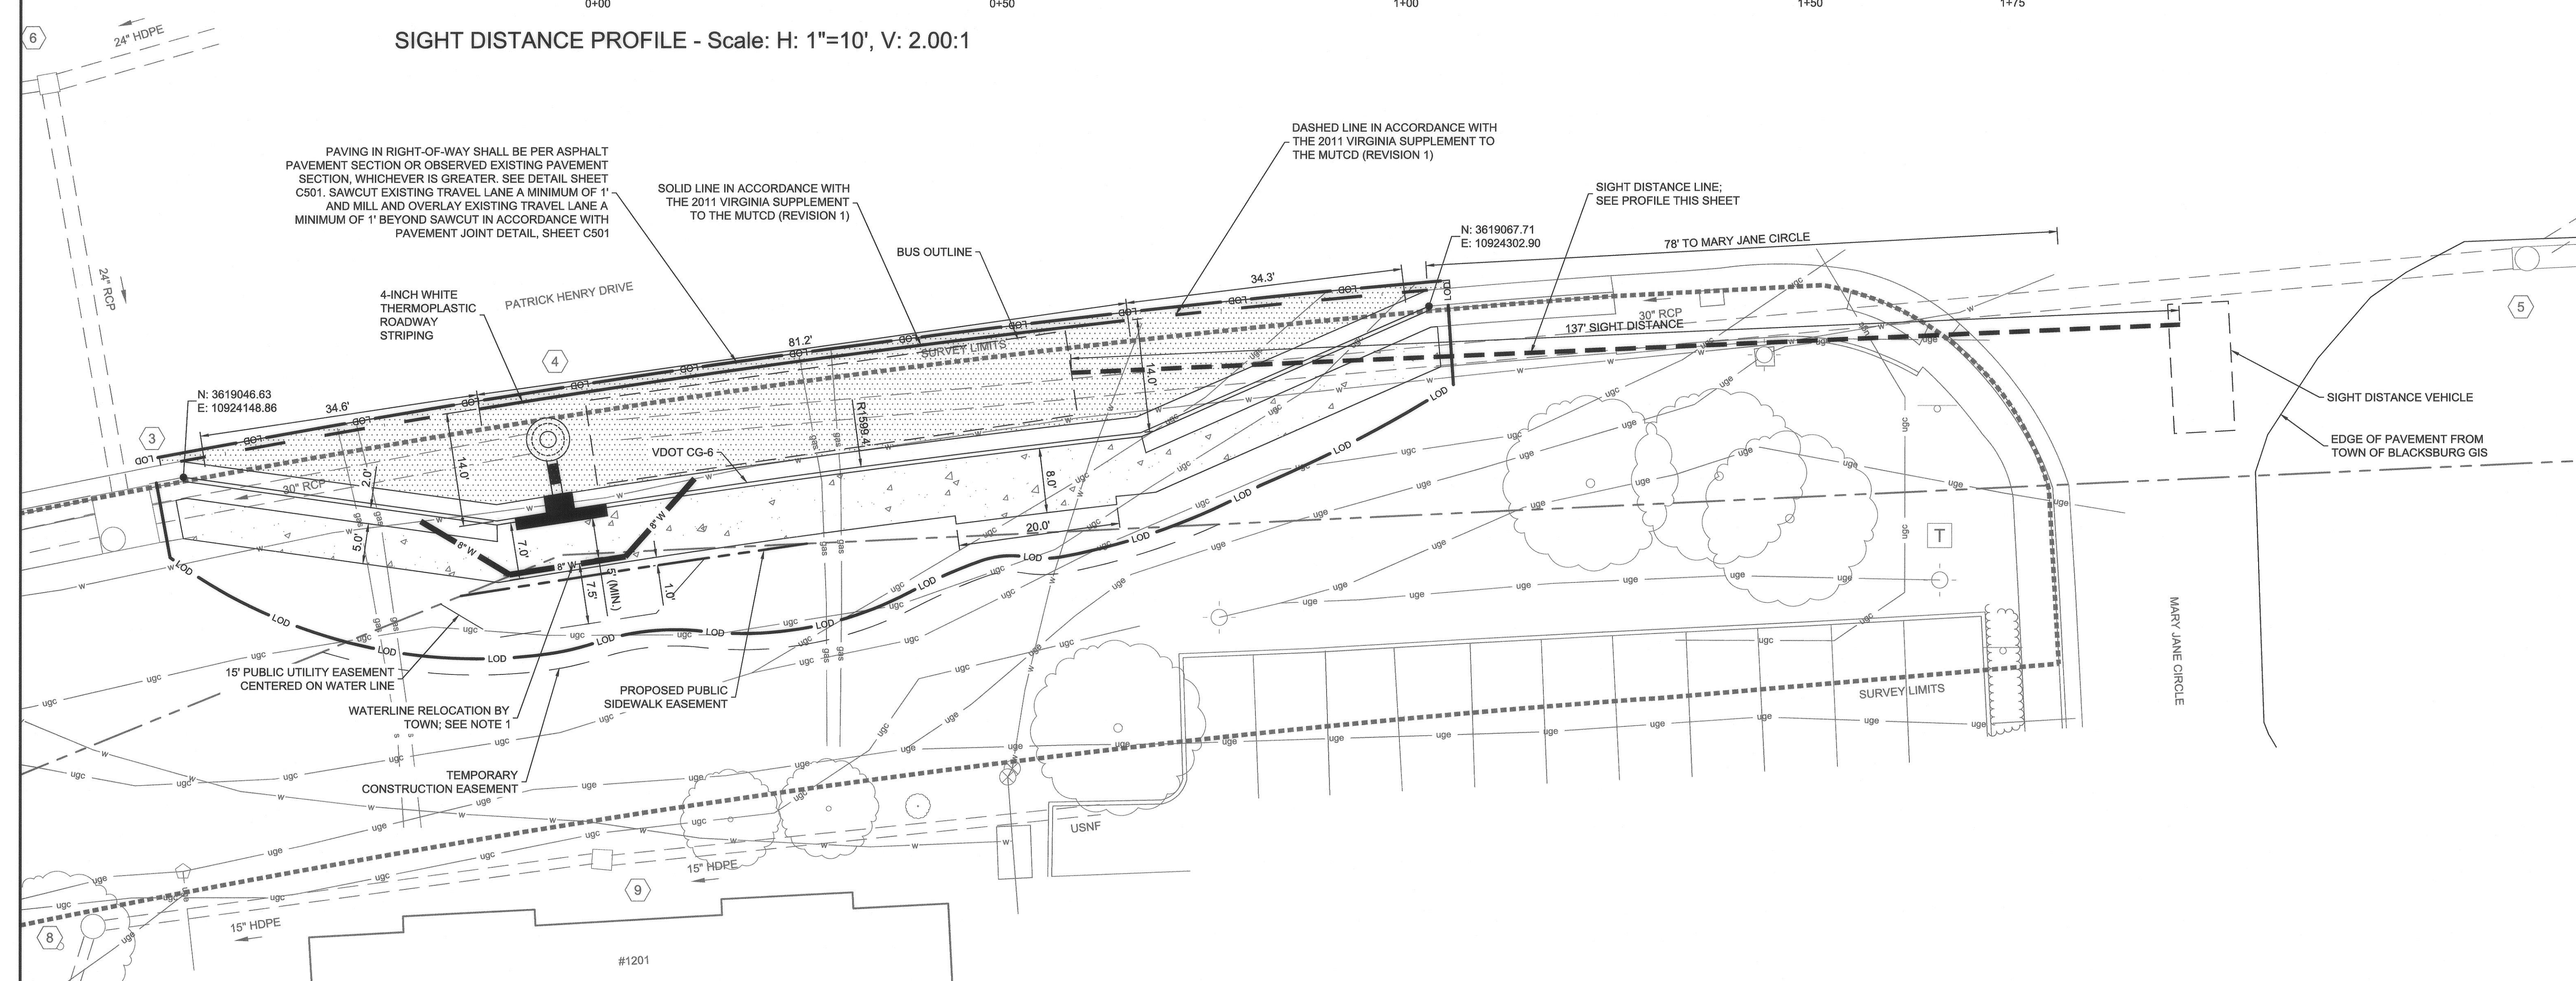

NOTES:
 1. WATERLINE RELOCATION BY TOWN PUBLIC WORKS DEPARTMENT AT THE OWNER'S EXPENSE. COORDINATE INSTALLATION WITH TOWN PRIOR TO CONSTRUCTION. SCHEDULE WORK WITH THE TOWN AT LEAST 2 WEEKS PRIOR TO INSTALLATION.

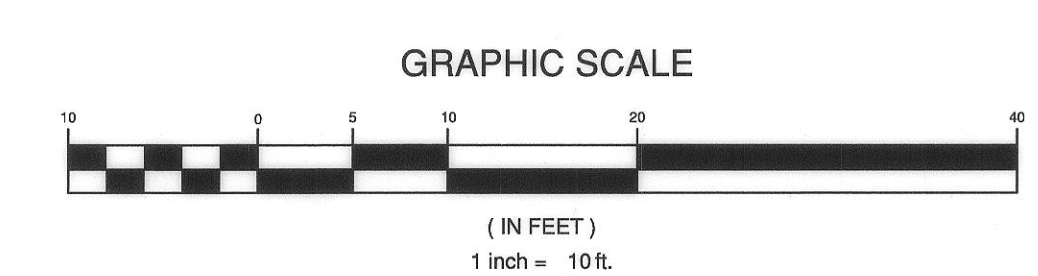

P:\2022\1020060\1020060\1020060_SDC\CA\2102060.dwg, 10/04/2022 7:16:44 AM, 10/04/2022 7:16:44 AM, SITE AND UTILITY PLAN, 10/04/2022 7:16:44 AM